


TERRACE FLOOR PLAN

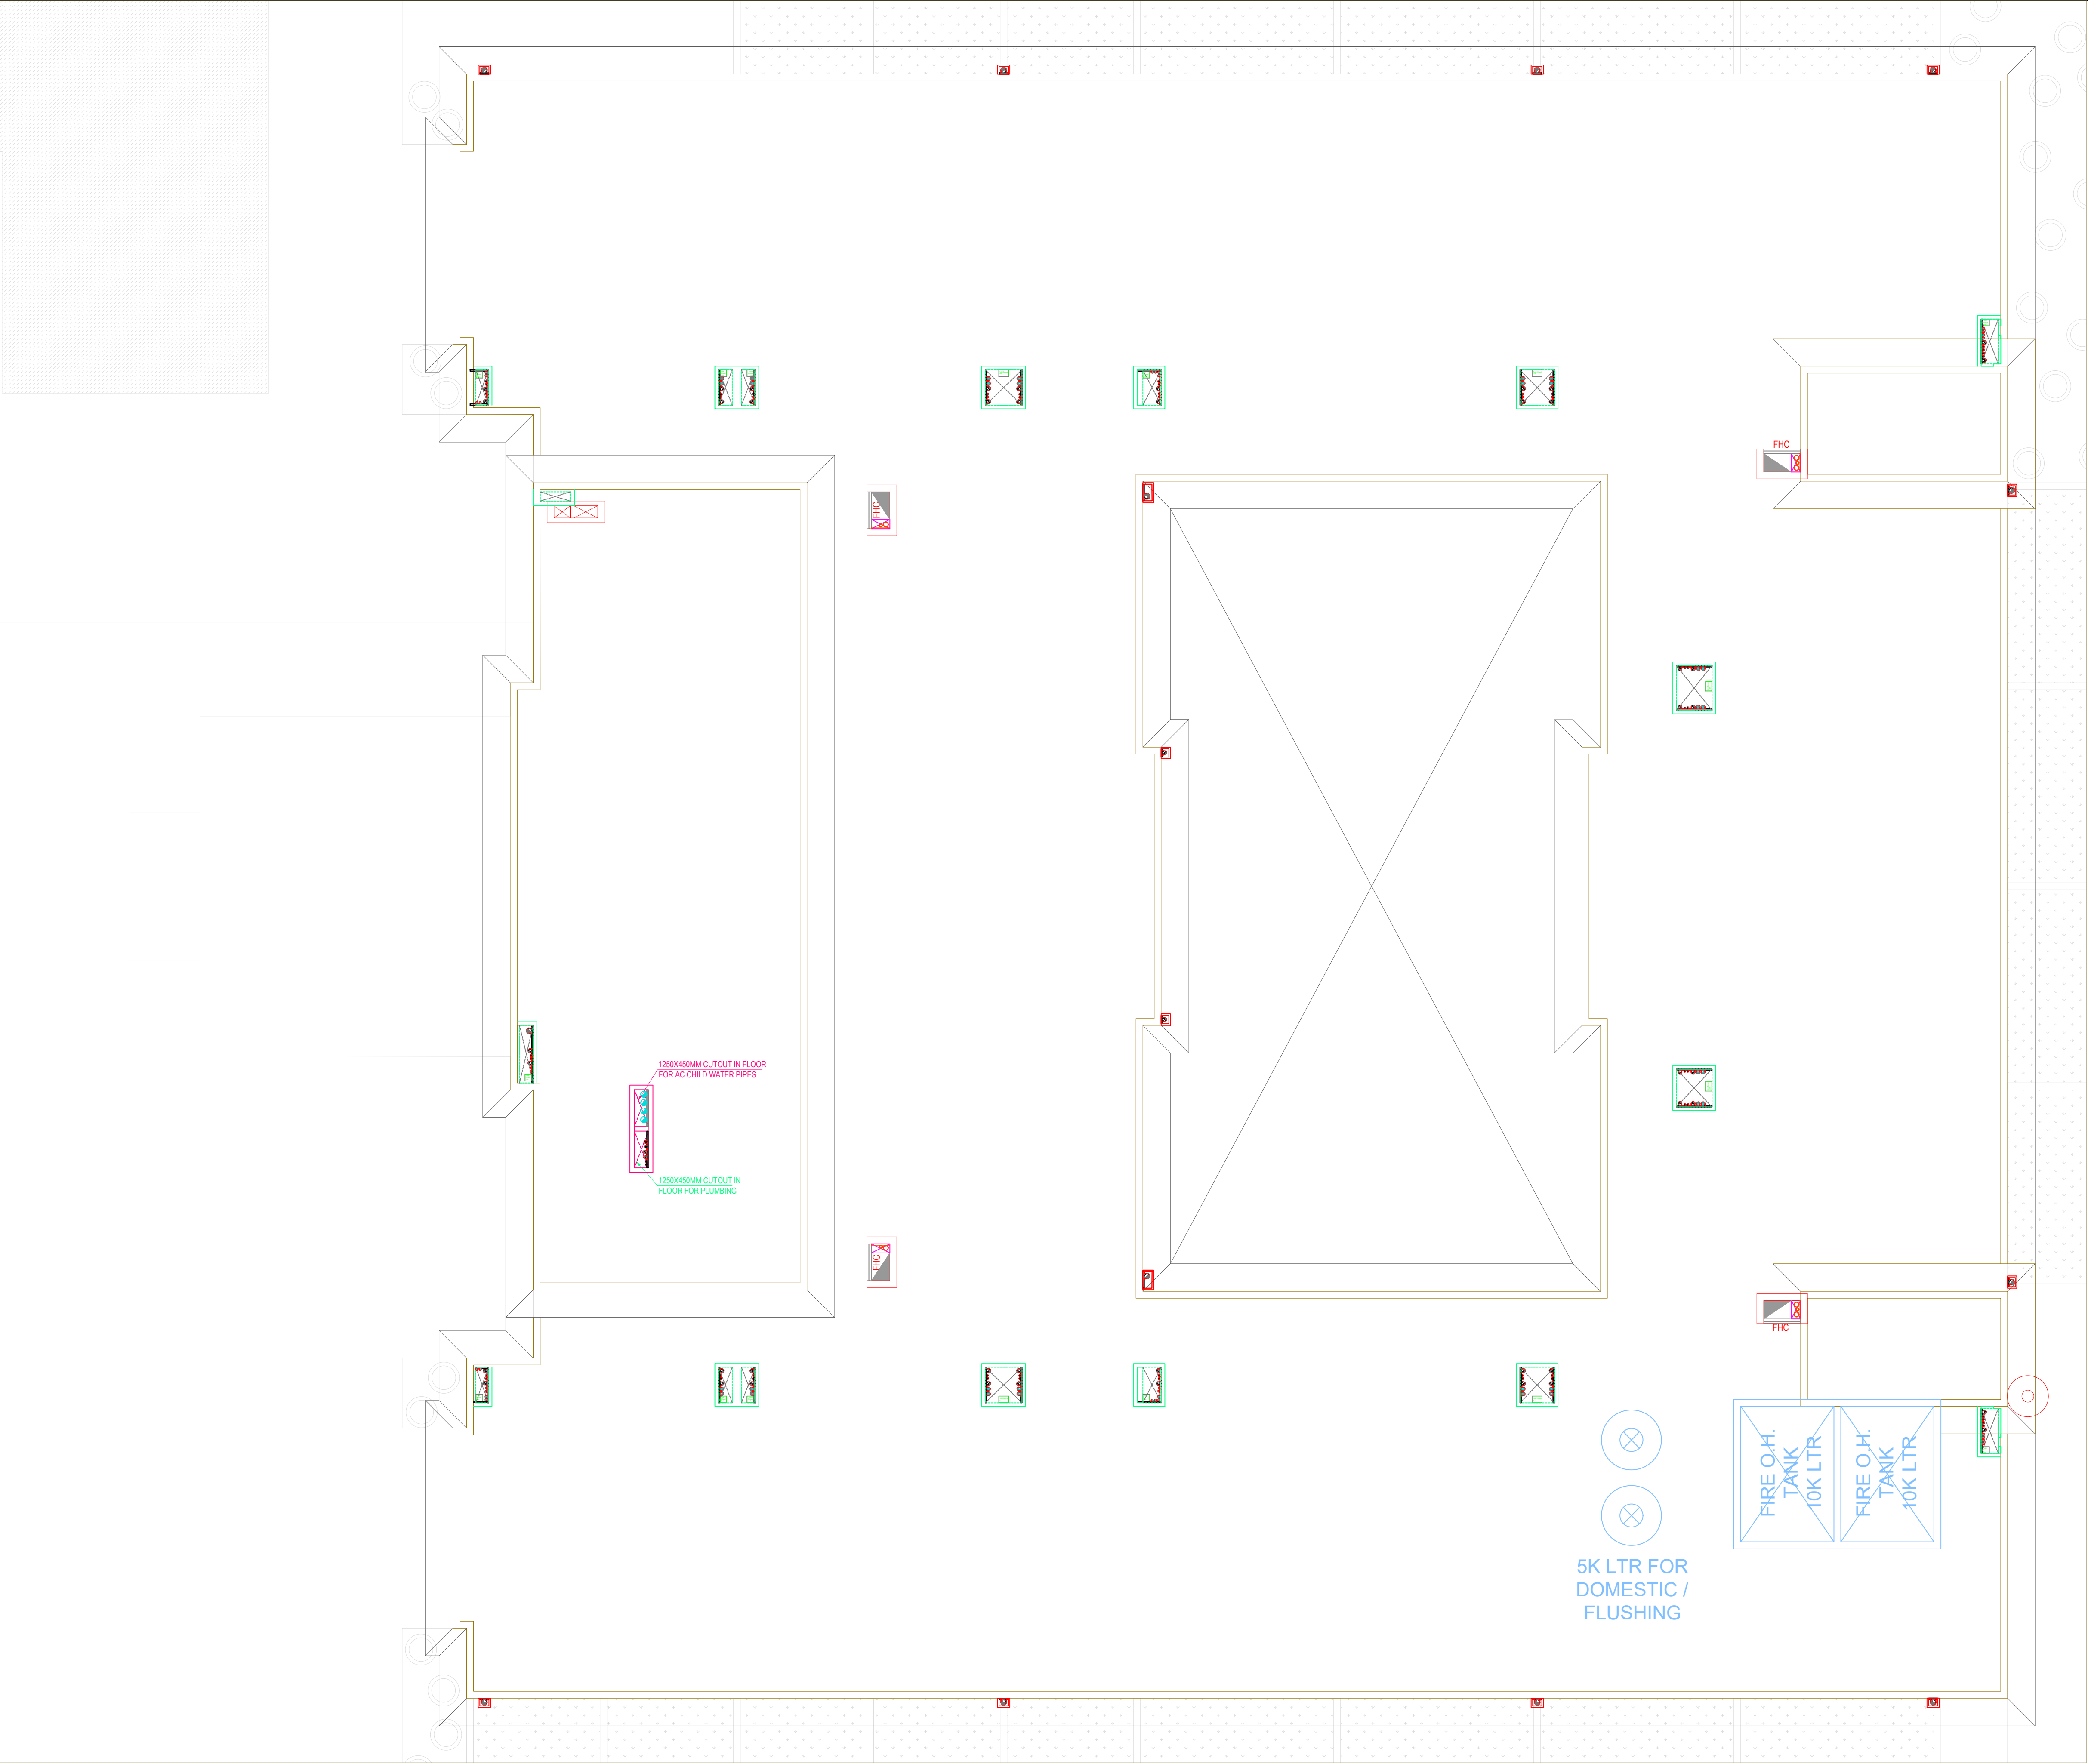

HVAC LEGEND	
—	CHILLED WATER SUPPLY PIPE
—	CHILLED WATER RETURN PIPE
—	HOT WATER SUPPLY PIPE
—	HOT WATER RETURN PIPE
—	TREATED FRESH AIR DUCT
—	TOILET EXHAUST DUCT

SCHEMATIC DRAWINGS		
REVISION NO.- R0		
MEPF CONSULTANT: NEWTECH CONSULTING ENGINEERS C-137/1, 3rd Floor, Vijay Vihar Phase - II (Rohini Sec.-1), New Delhi – 110085. (India)		
ARCHITECT: RAVI KUMAR GUPTA CA/83/7739 L-1, KRISHNA MARG, C- SCHEME, JAIPUR (302001), RAJASTHAN. PH.0141-2360825 E-Mail-ravigupta_15@yahoo.com		
DRAWING TITLE: TERRACE FLOOR PLAN (HVAC LAYOUT)		
PROJECT: LAXMI PALACE / HOTEL		
DRAWN BY: SONU KUMAR	NORTH:	DATE: 09-01-2024
CHECKED BY: VIJAY KUMAR	DRAWING NO.: AC-03	SCALE: 1:100
NOTES: THE COPYRIGHT AND PROPERTY OF THIS DESIGN AND DRAWING BELONGS TO RAVI KUMAR GUPTA . IT MUST NOT BE COPIED OR REPRODUCED IN ANY MANNER WITHOUT THEIR WRITTEN CONSENT. A LEGAL ACTION AS PER LAW MAY BE INITIATED AGAINST THE OFFENDER. 02		
STRUCTURE CO. : SANRACHANA		