
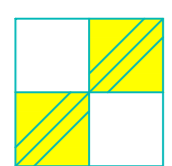


WATER DRAINAGE PIPE SCHEDULE

PIPE NO.	SIZE	SLOPE
(A)	50ø	1:90
(B)	75ø	1:110
(C)	110ø	1:110
(D)	150ø	1:200

LEGEND: -

- 1. SOIL PIPE █
- 2. WASTE PIPE █
- 3. KITCHEN DRAIN PIPE █
- 4. DRAIN POINT ●
- 5. CLEAN OUT PLUG (GØP) ●

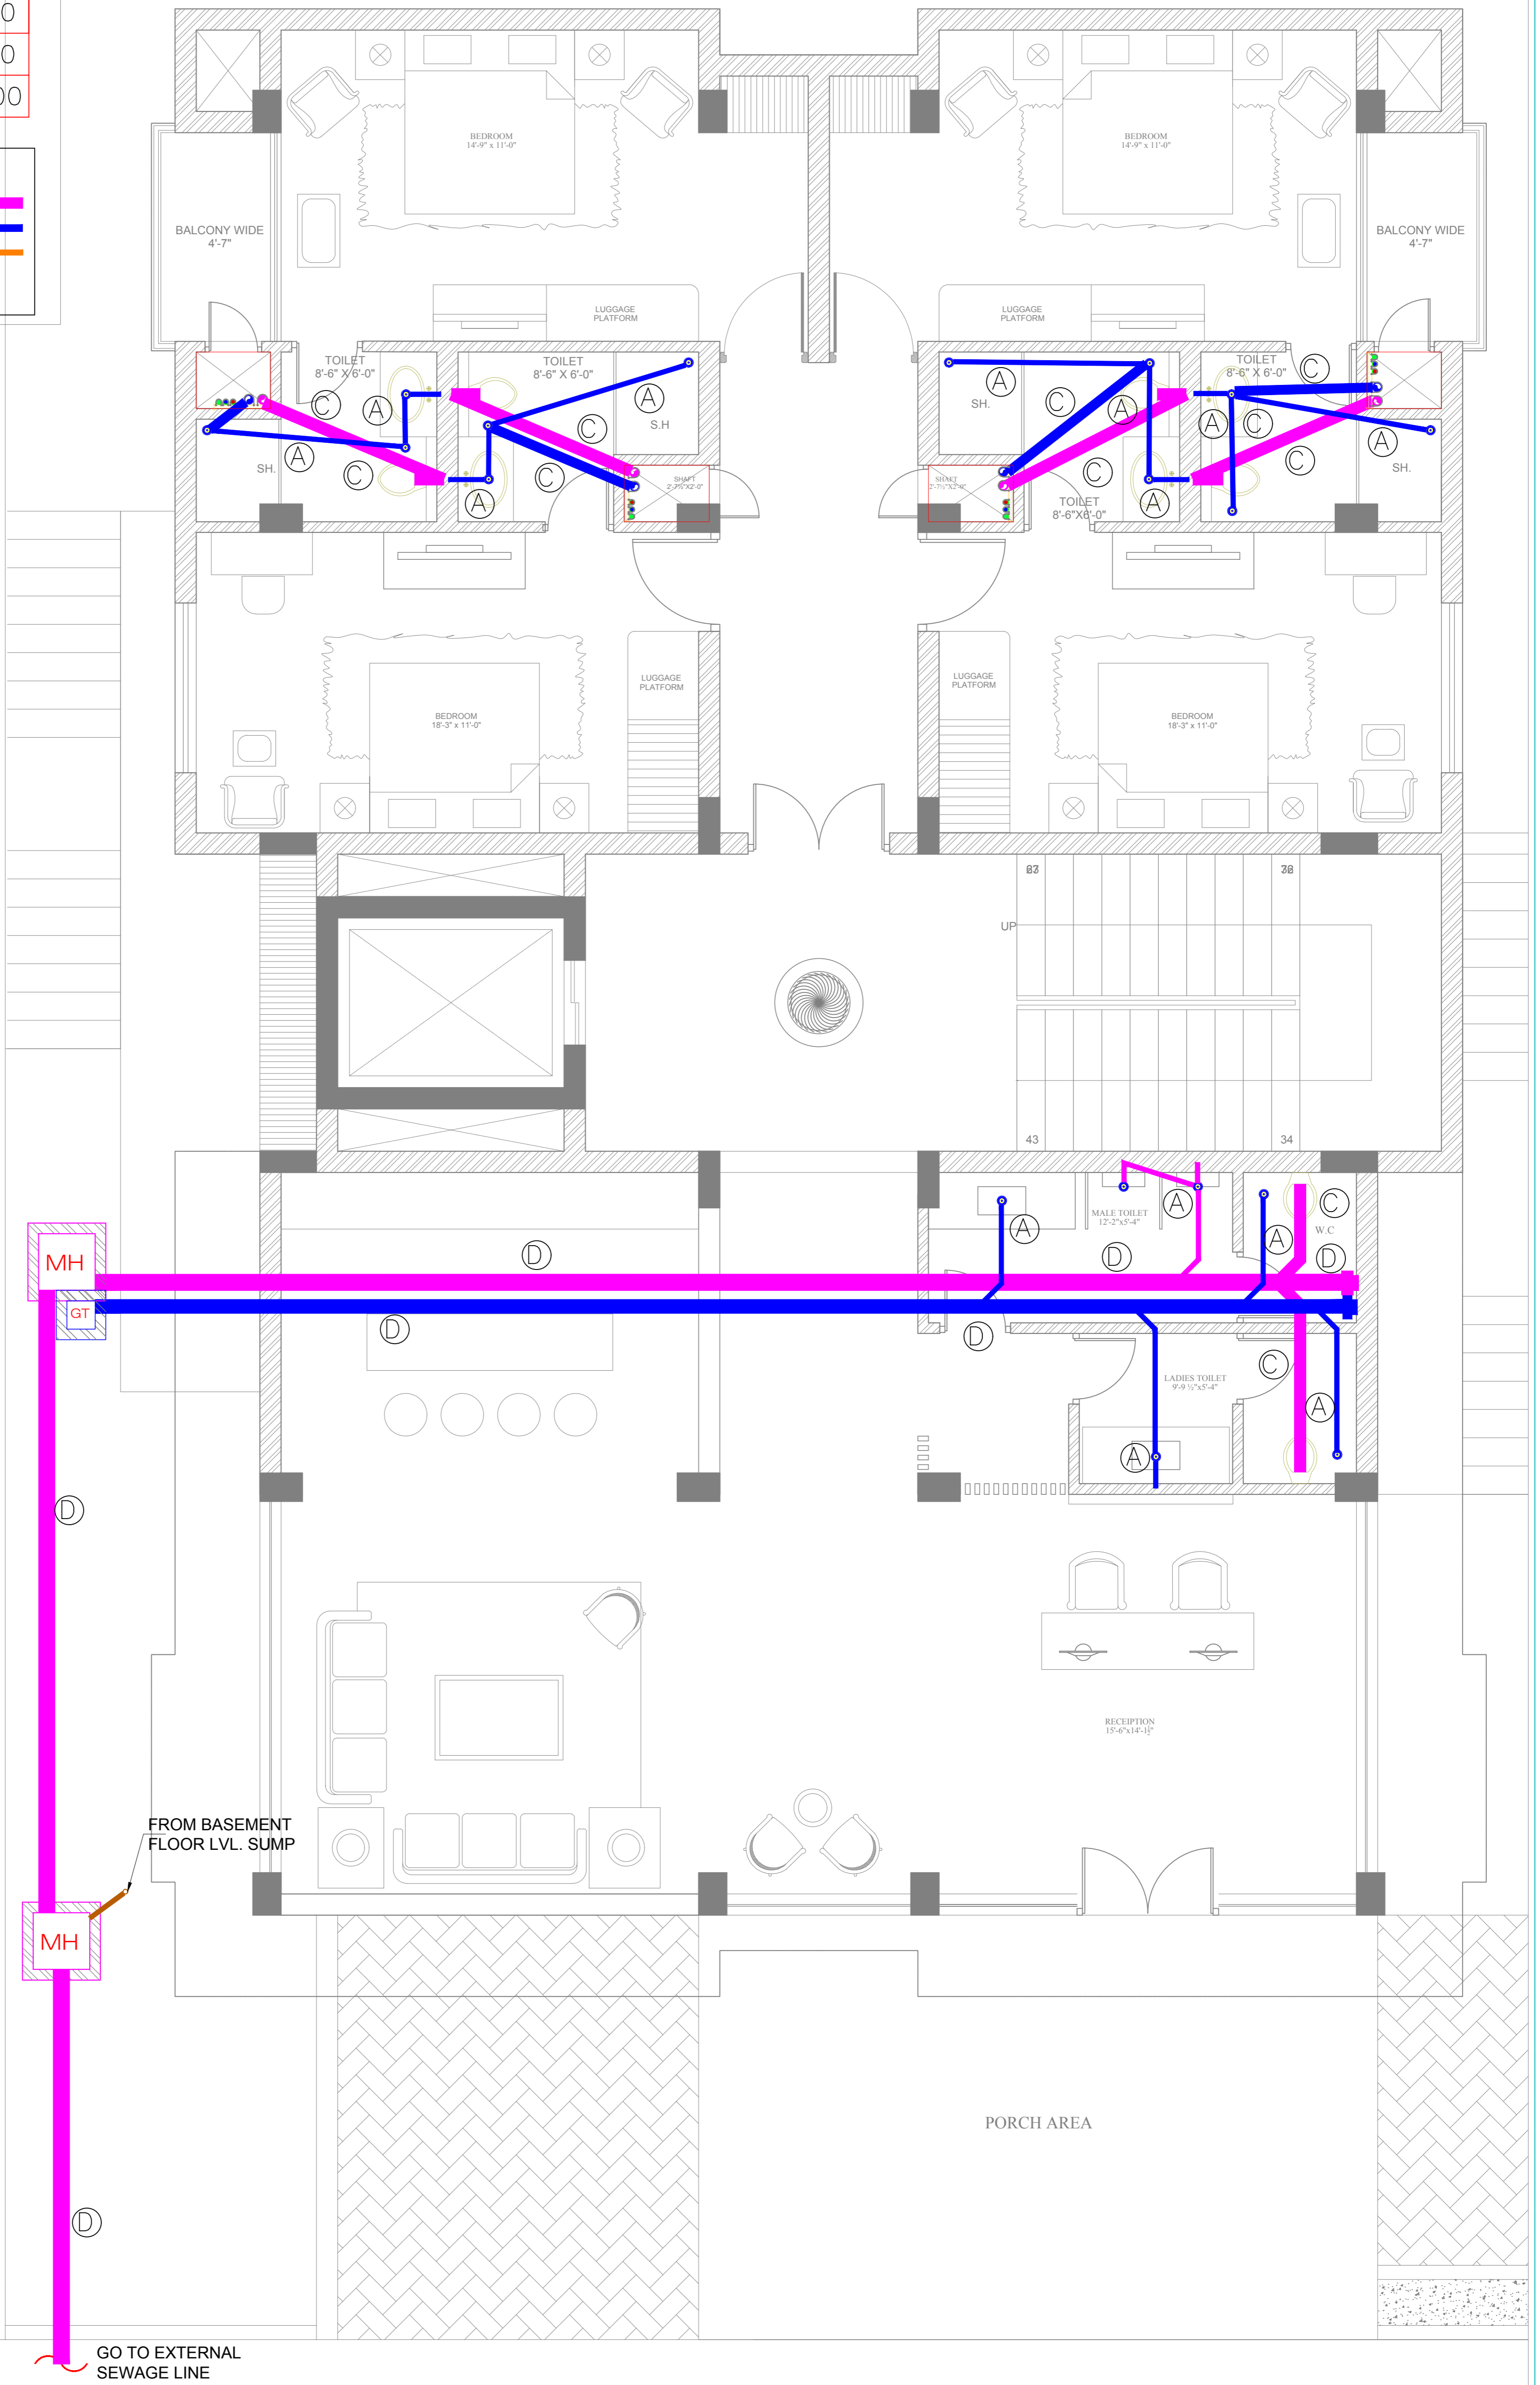

SAN ENGINEERS & CONSULTANTS
307, ASHWARYA TOWER, AJMER ROAD, JAIPUR
+91-99295-97301
E-mail: sanecpl@gmail.com

PROJECT NO:42
DRAWING NO: NG/HCL/PLU./03
REVISION NO:01
17.03.2018

SCALE: N.T.S.

GROUND FLOOR PLUMBING DRAINAGE LAYOUT

ARCHITECTS

NEERAV GUPTA

L-1, KRISHNA MARG, C- SCHEME,
JAIPUR (302001), RAJASTHAN.
PH.0141-2360825

E-Mail- architect_neeravgupta@yahoo.com

HOTEL CLARKS,
LUCKNOW