


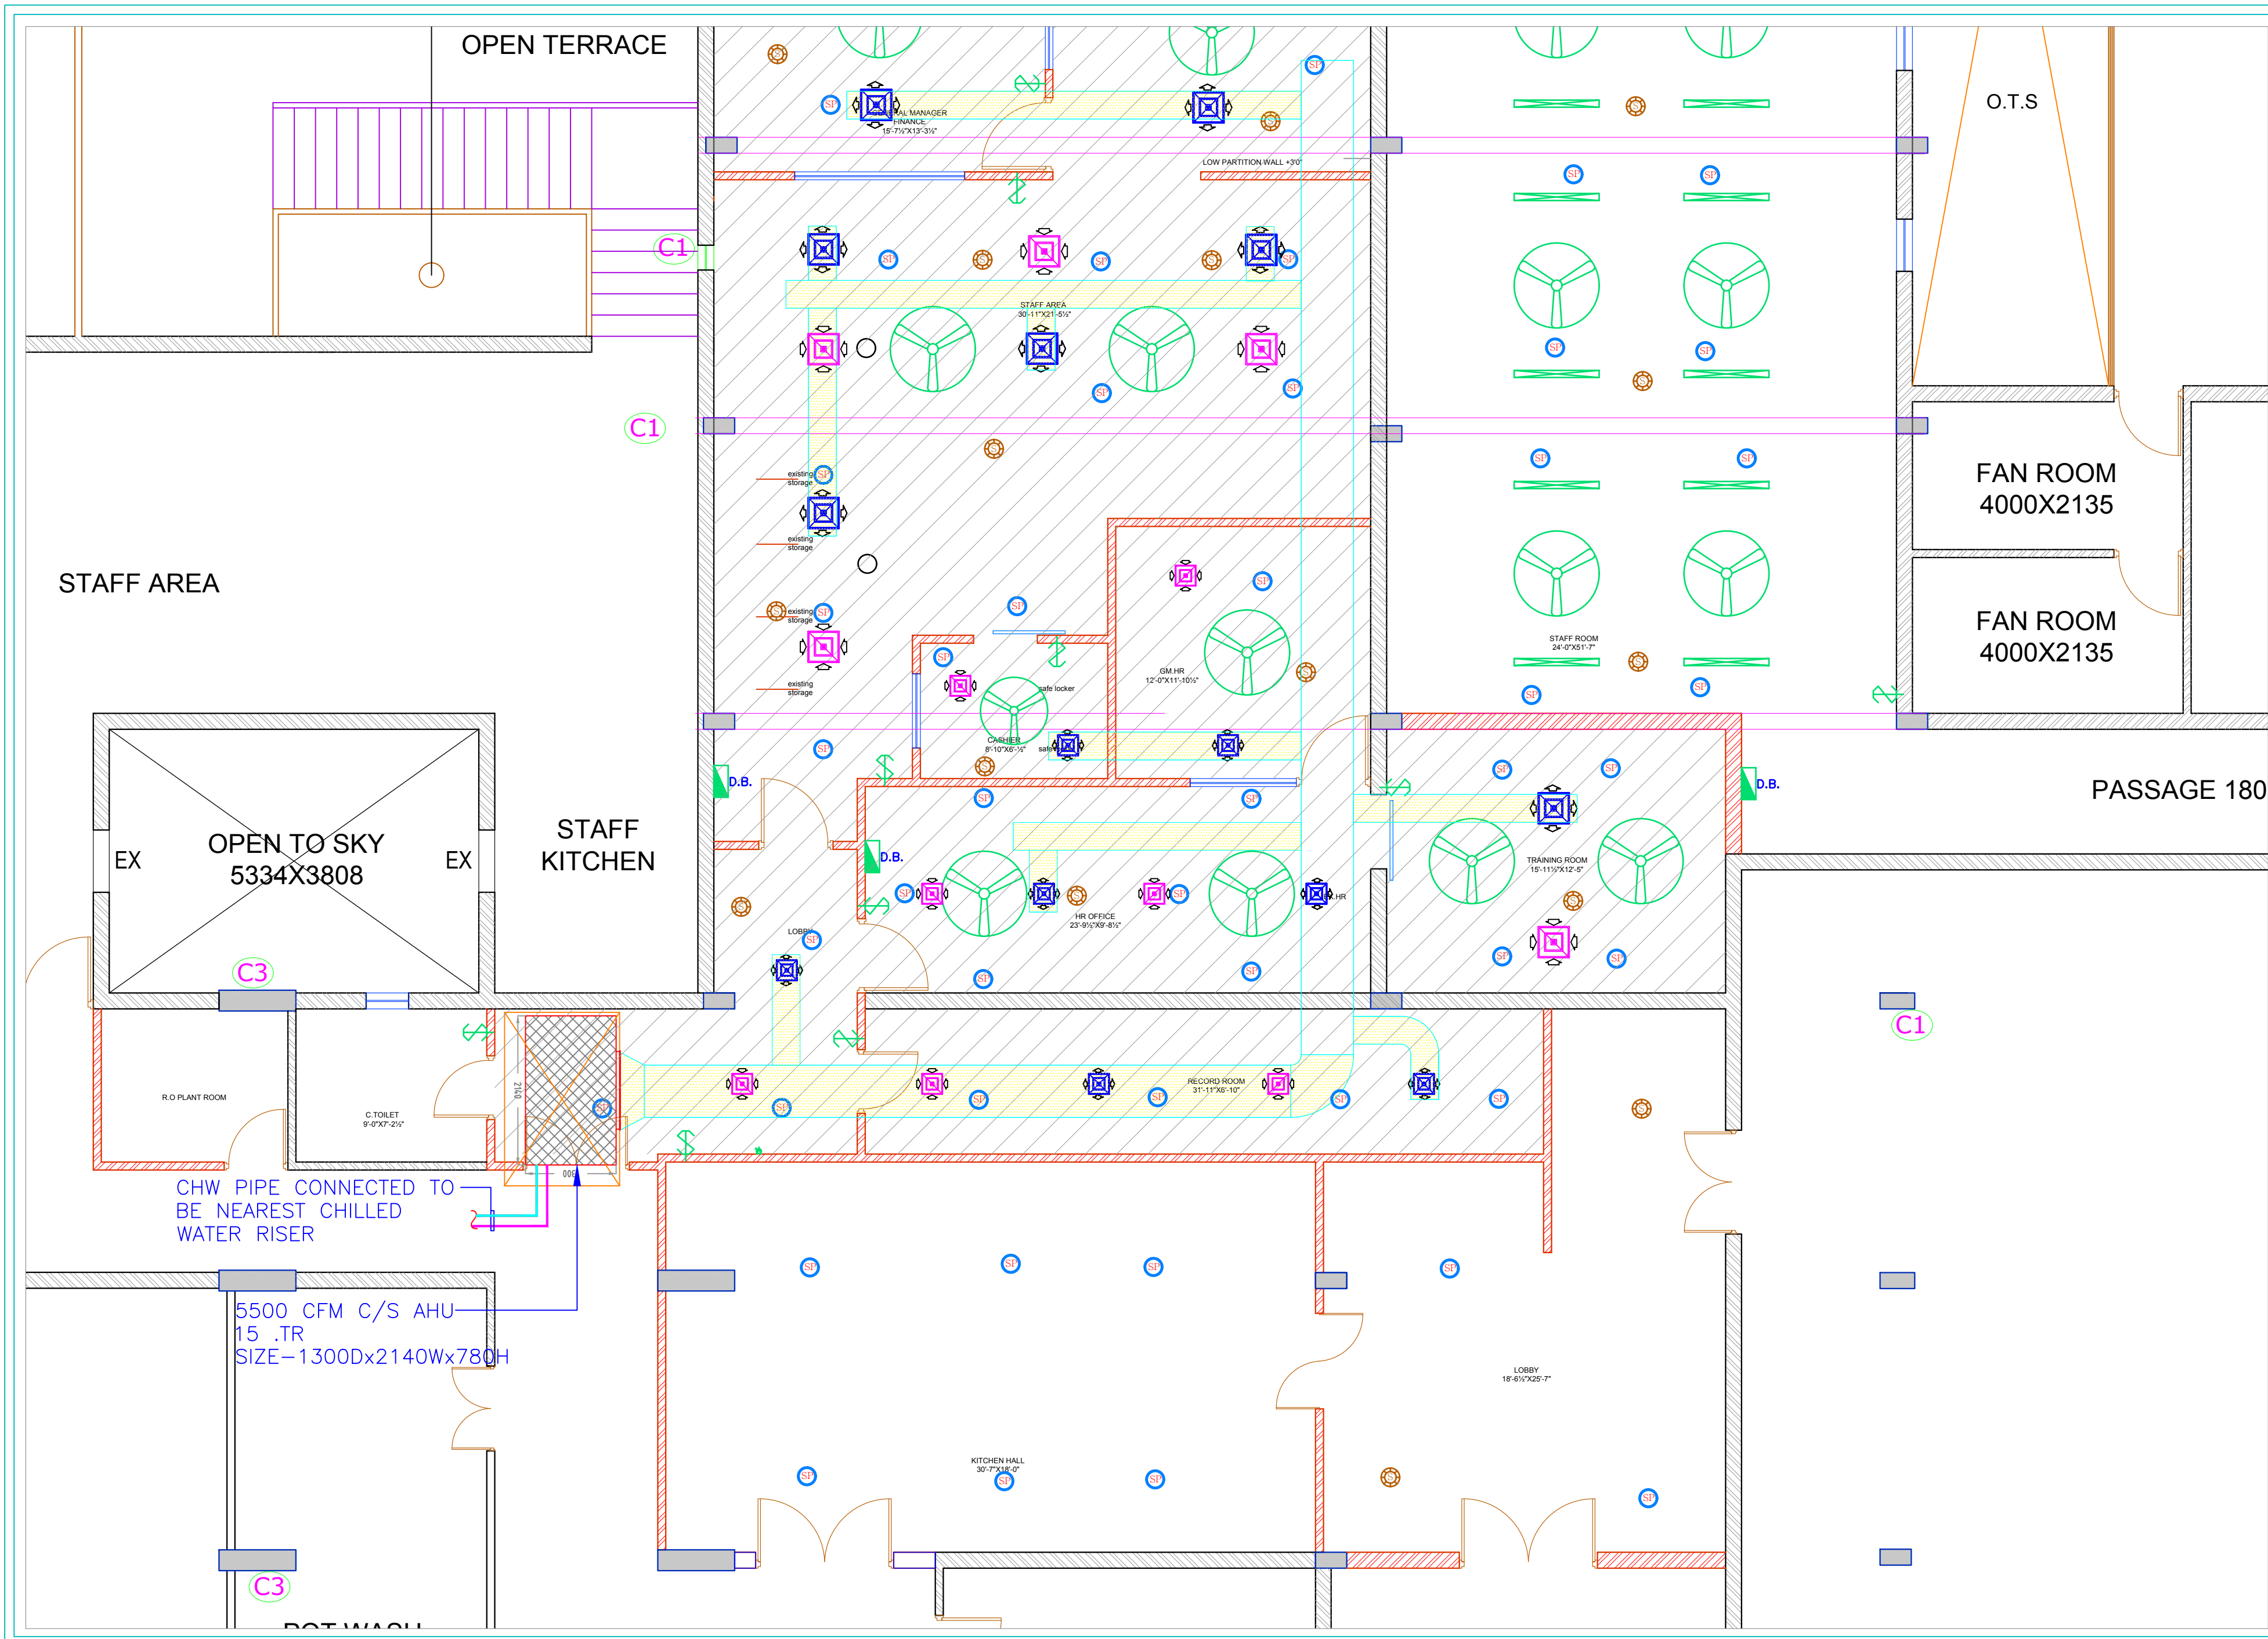

HOTEL CLARKS,
LUCKNOW

ARCHITECTS
NEERAV GUPTA
L-1, KRISHNA MARG, C- SCHEME,
JAIPUR (302001), RAJASTHAN.
PH.0141-2360825
E-Mail- architect_neeravgupta@yahoo.com

FIRST FLOOR OFFICE AREA
HVAC LAYOUT

SCALE: N.T.S.
PROJECT NO:
DRAWING NO:
C/A/V/ARCH/IVAC/01
REVISION NO:
25.08.2018

SAN ENGINEERS & CONSULTANTS
G-2, 1055 CHITRAKOOT SCHEME, NEAR PRATAP STADIUM,
VALENTIA, JAIPUR
+91-141-4026831
E-mail: saneyd@gmail.com